



ATTIC PLAN
SCALE: 1/4" = 1'-0"

ALL WORK AS INDICATED ON THESE PLANS SHALL BE DONE IN ACCORDANCE WITH THE FOLLOWING CODES:


- 2021 INTERNATIONAL RESIDENTIAL CODE - NJ EDITION
- UNIFORM CONSTRUCTION CODE FOR NJ- SUBCHAPTER 6
- 2021 INTERNATIONAL MECHANICAL CODE
- 2020 NFPA 70 NATIONAL ELECTRICAL CODE
- 2021 NATIONAL STANDARD PLUMBING CODE
- 2021 INTERNATIONAL FUEL GAS CODE
- ASHRAE STANDARD 90.1-2019

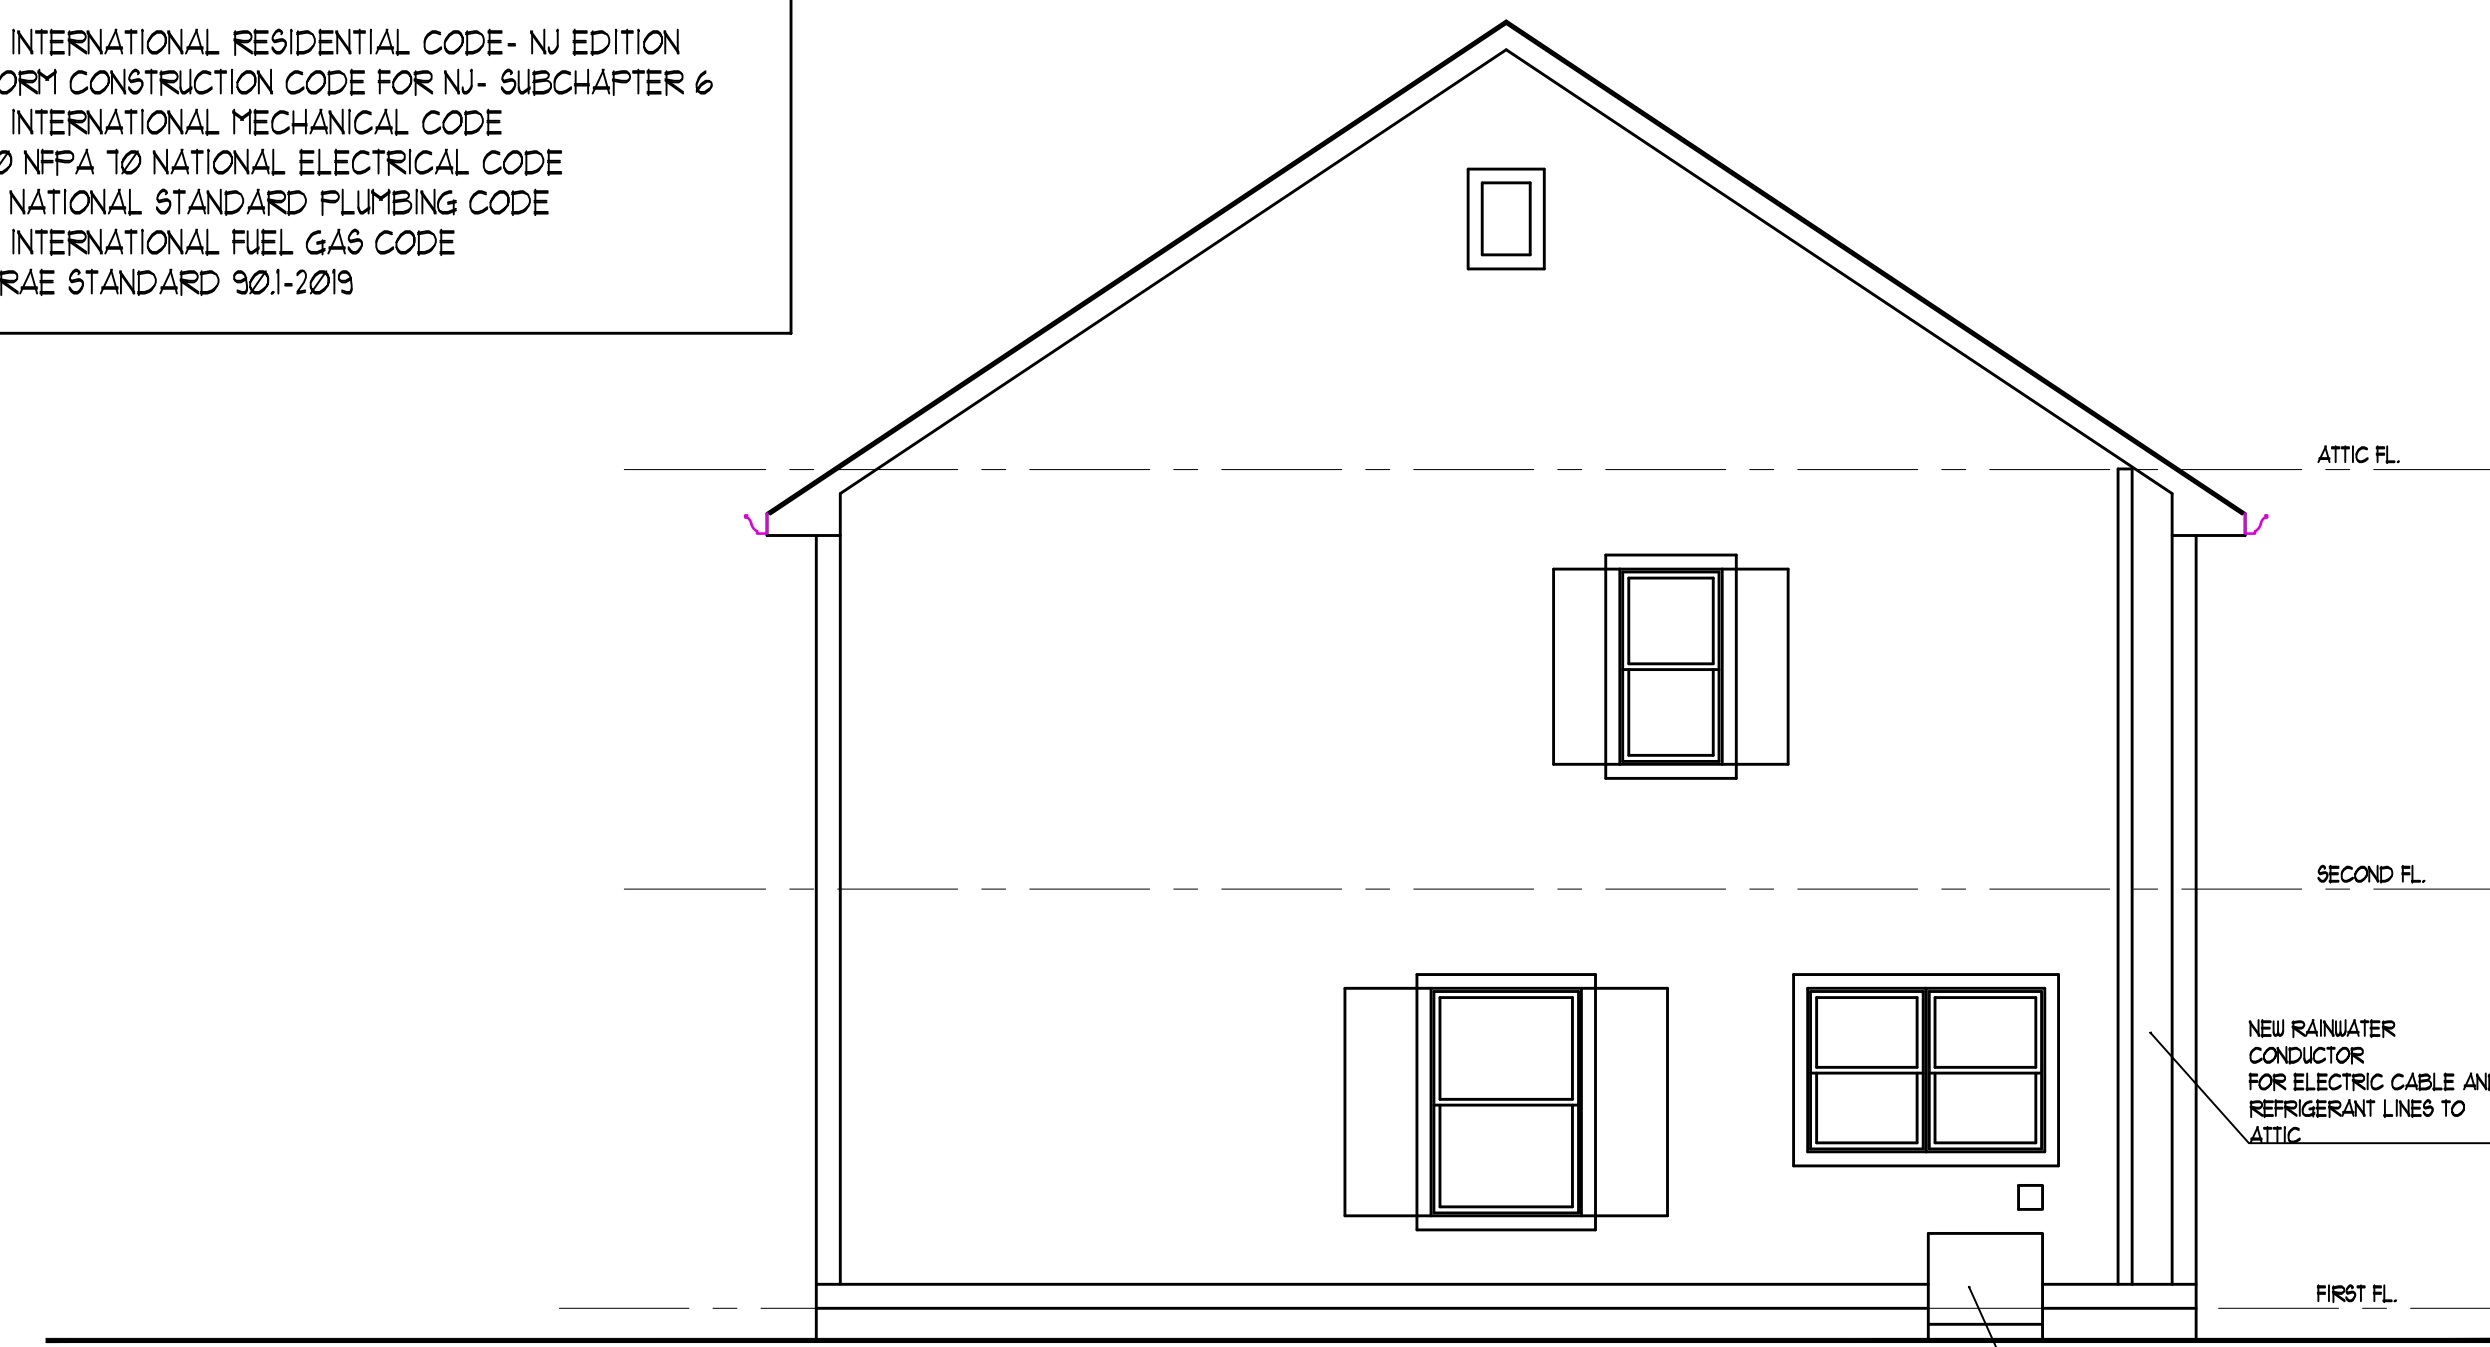


SIDE ELEV.
SCALE: 1/4" = 1'-0"

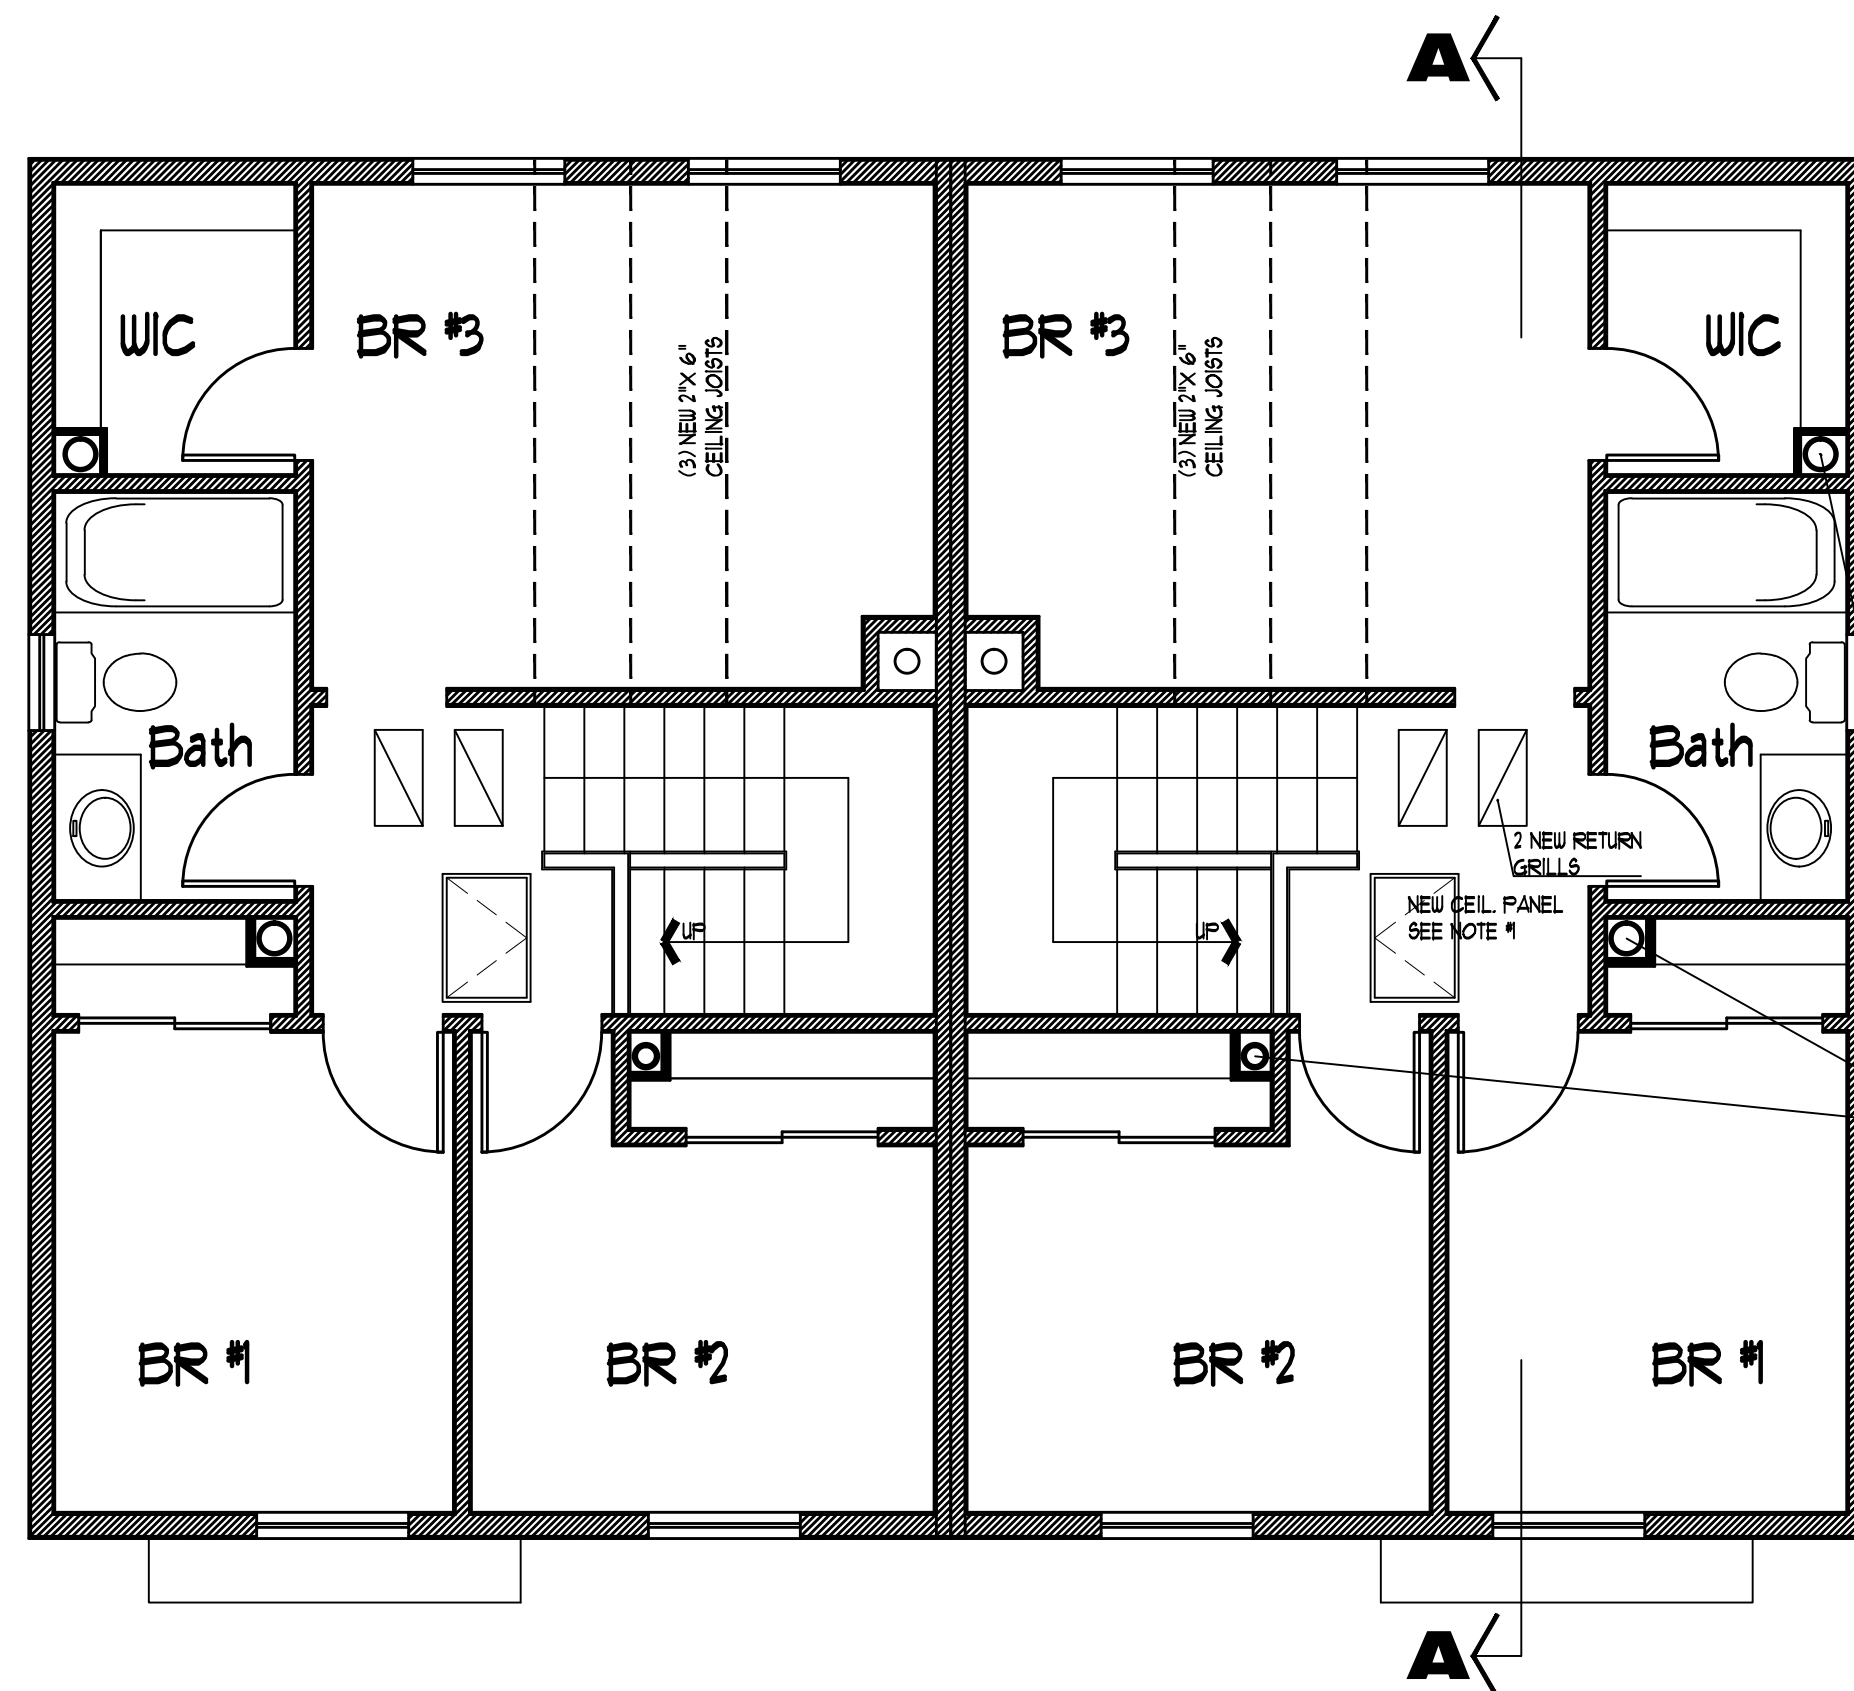

2nd FLOOR PLAN
SCALE: 1/4" = 1'-0"

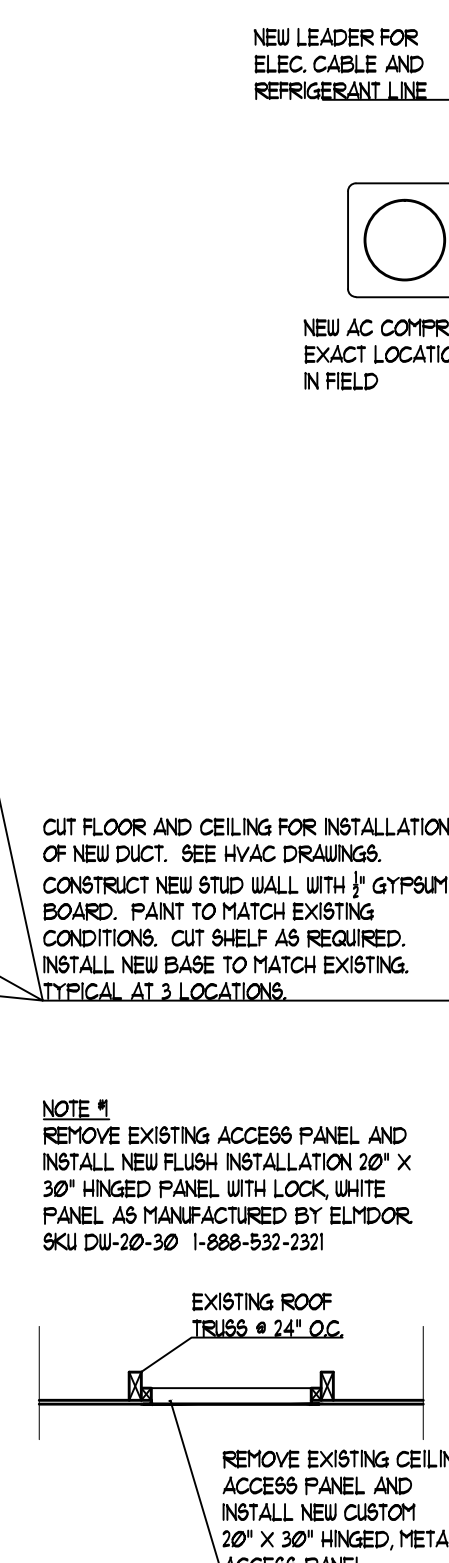

DETAIL
SCALE: 1/4" = 1'-0"

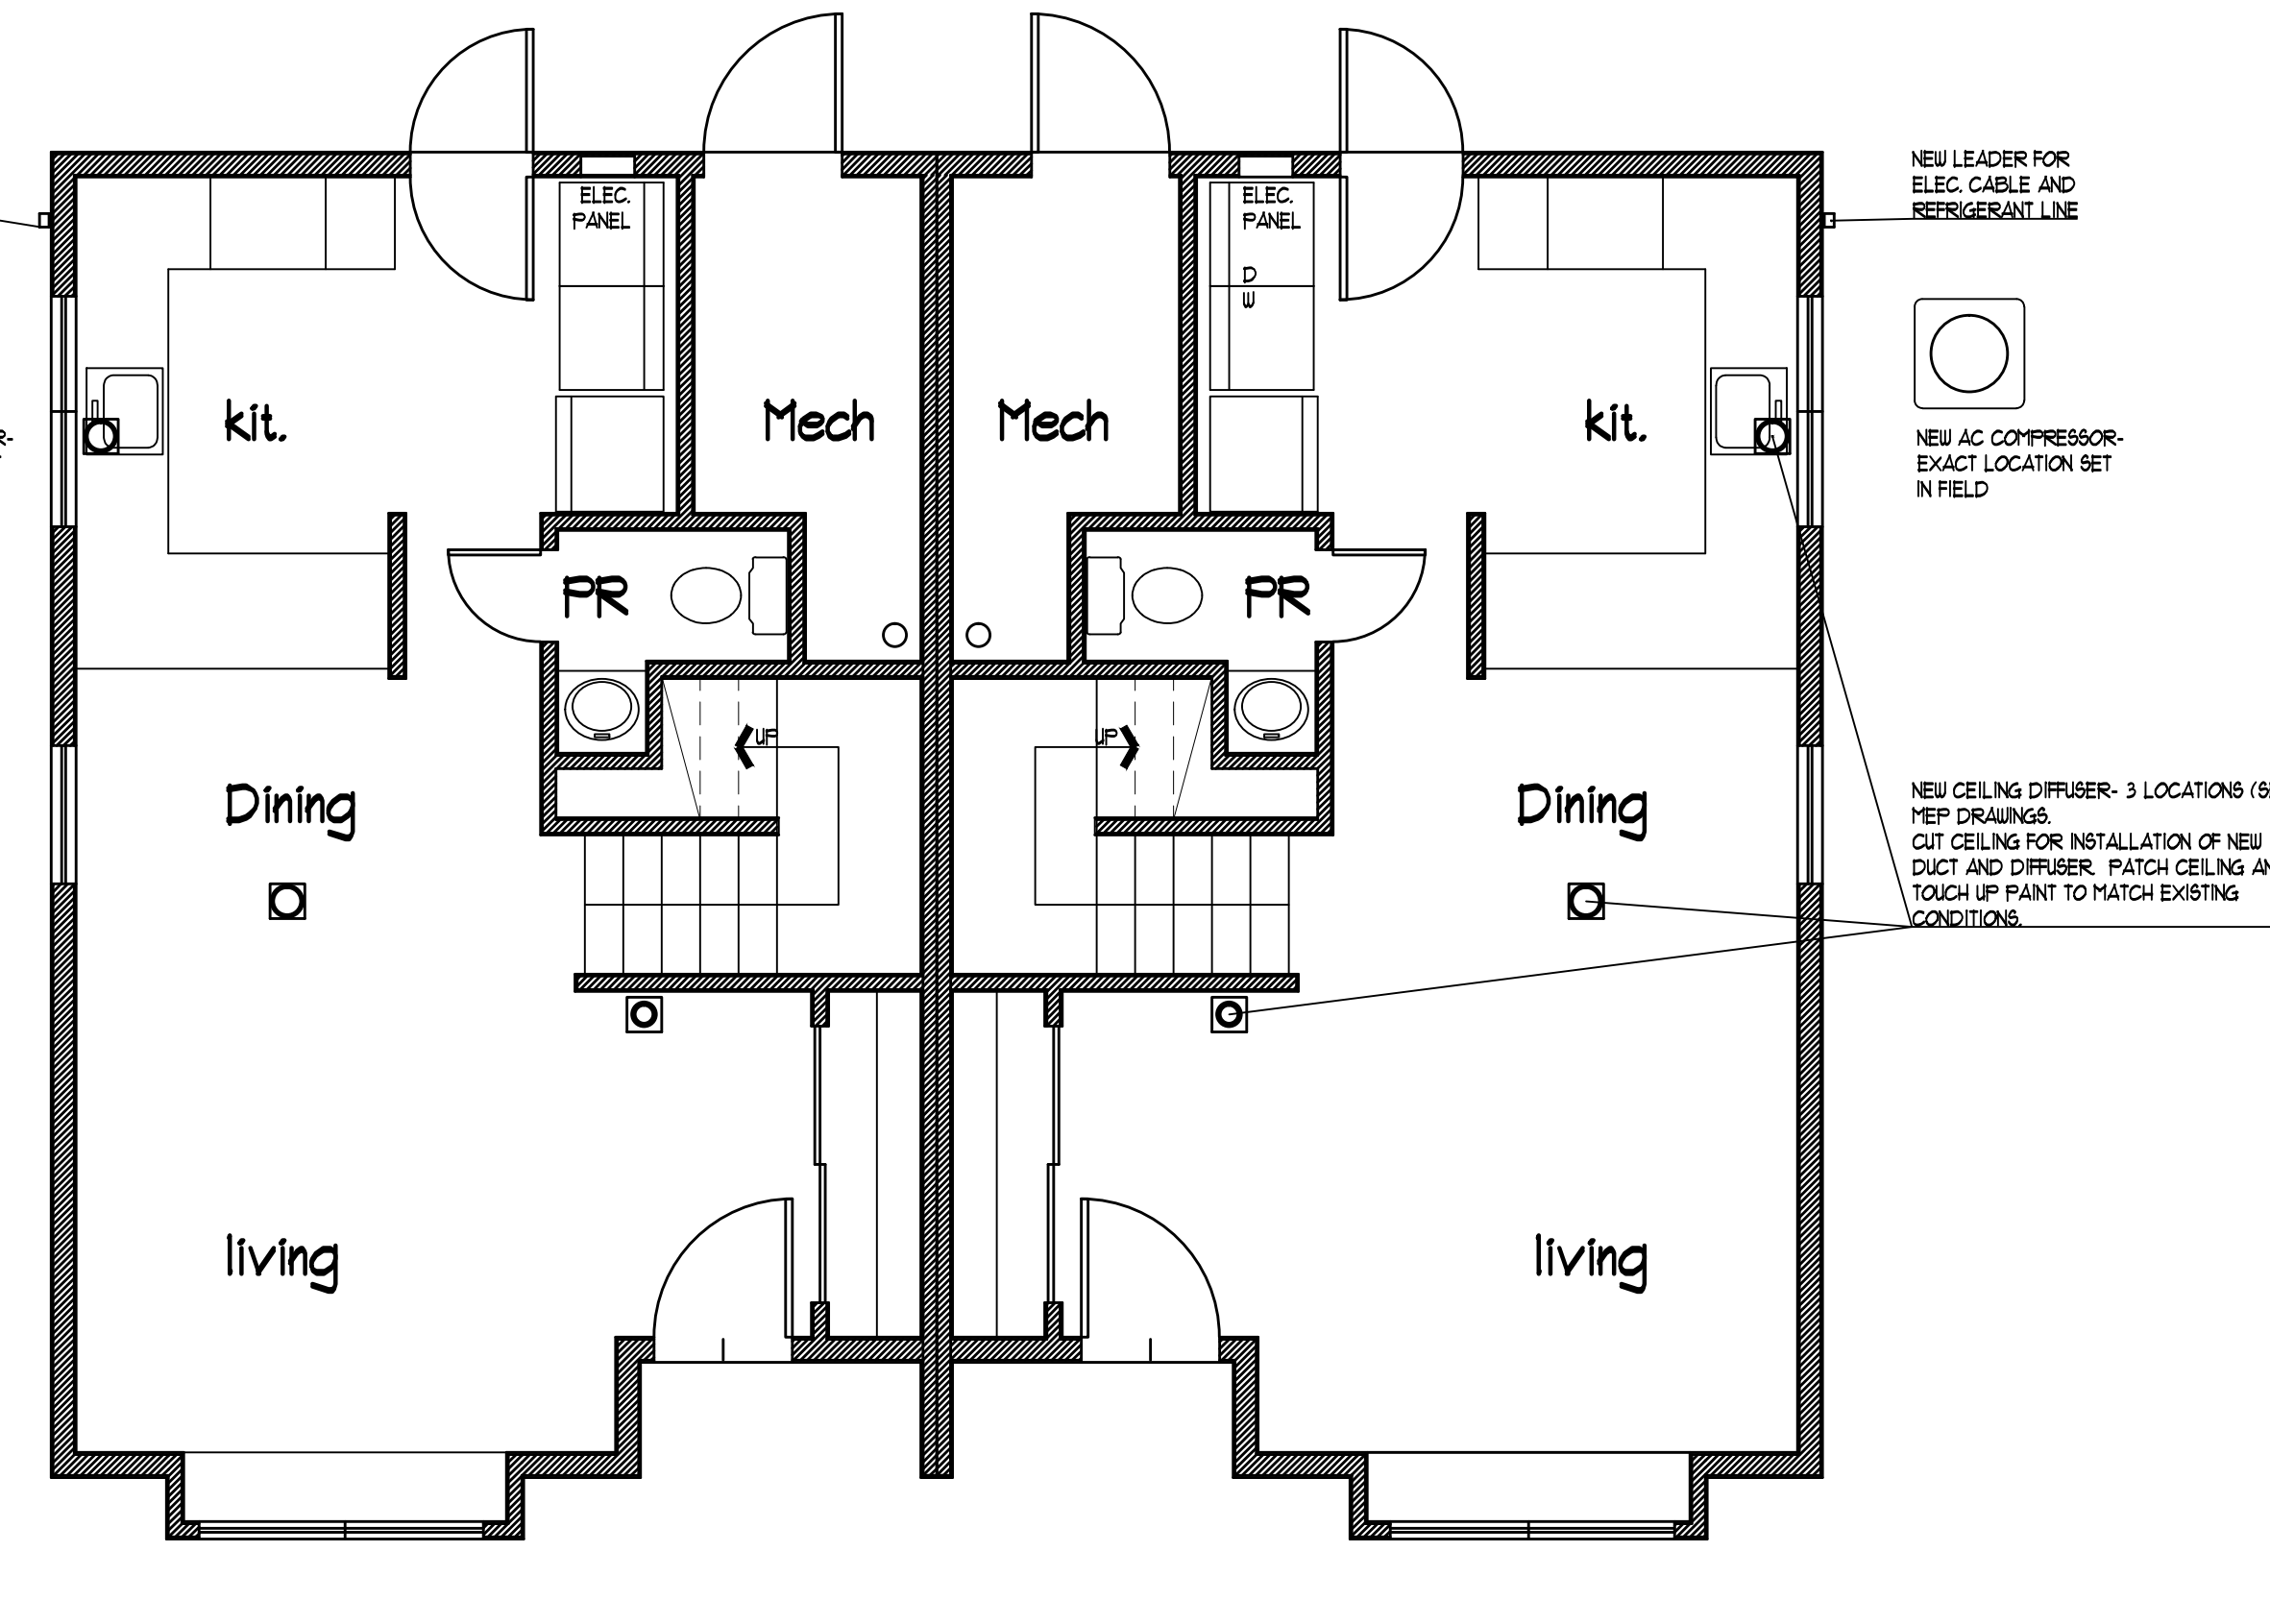

1st FLOOR PLAN
SCALE: 1/4" = 1'-0"

REVISIONS
WILLIAM CHARLEROY - ARCHITECT 114 TITUS MILL ROAD SUITE 103 PENNINGTON, NEW JERSEY 08534 (609) 131-3091
AIR CONDITIONING PROJECT AT THE LOANTAKA WAY HOUSING SITE MADISON, N.J. FOR THE MADISON HOUSING AUTHORITY
W. CHARLEROY RA AIA NJ ARCHITECT C-9141 PA. ARCHITECT RA02848B
A2
DATE: APRIL 17, 2023